



LEGEND

- ⊙ = TREE
- E = ELECTRICAL LOCATION
- = GUY WIRE
- ⊕ = POWER POLE
- T = TELEPHONE LOCATION
- G = GAS LOCATION
- W = WATER LOCATION
- SMH = SANITARY MANHOLE
- STMH = STORM MANHOLE
- △ = TELEPHONE PEDESTAL
- ⊕ = STREET SIGN
- △C = CABLE T.V.
- ⊕ = FIRE HYDRANT
- ⊕ = CATCH BASIN
- ⊕ = WATER VALVE
- ⊕ = TELEPHONE POLE
- ⊕ = WATER CURB STOP
- ⊕ = UTILITY POLE
- ⊕ = TRAFFIC SIGN
- ⊕ = BORING LOCATION
- ⊕ = GAS VALVE
- ⊕ = WATER METER
- ⊕ = GUARD POST
- ⊕ = LIFT STATION
- ⊕ = LIGHT POLE
- ⊕ = SHRUB
- ⊕ = ELECTRIC MANHOLE
- ⊕ = HANDICAP
- ⊕ = CURB CATCH BASIN
- ⊕ = SIGN POST

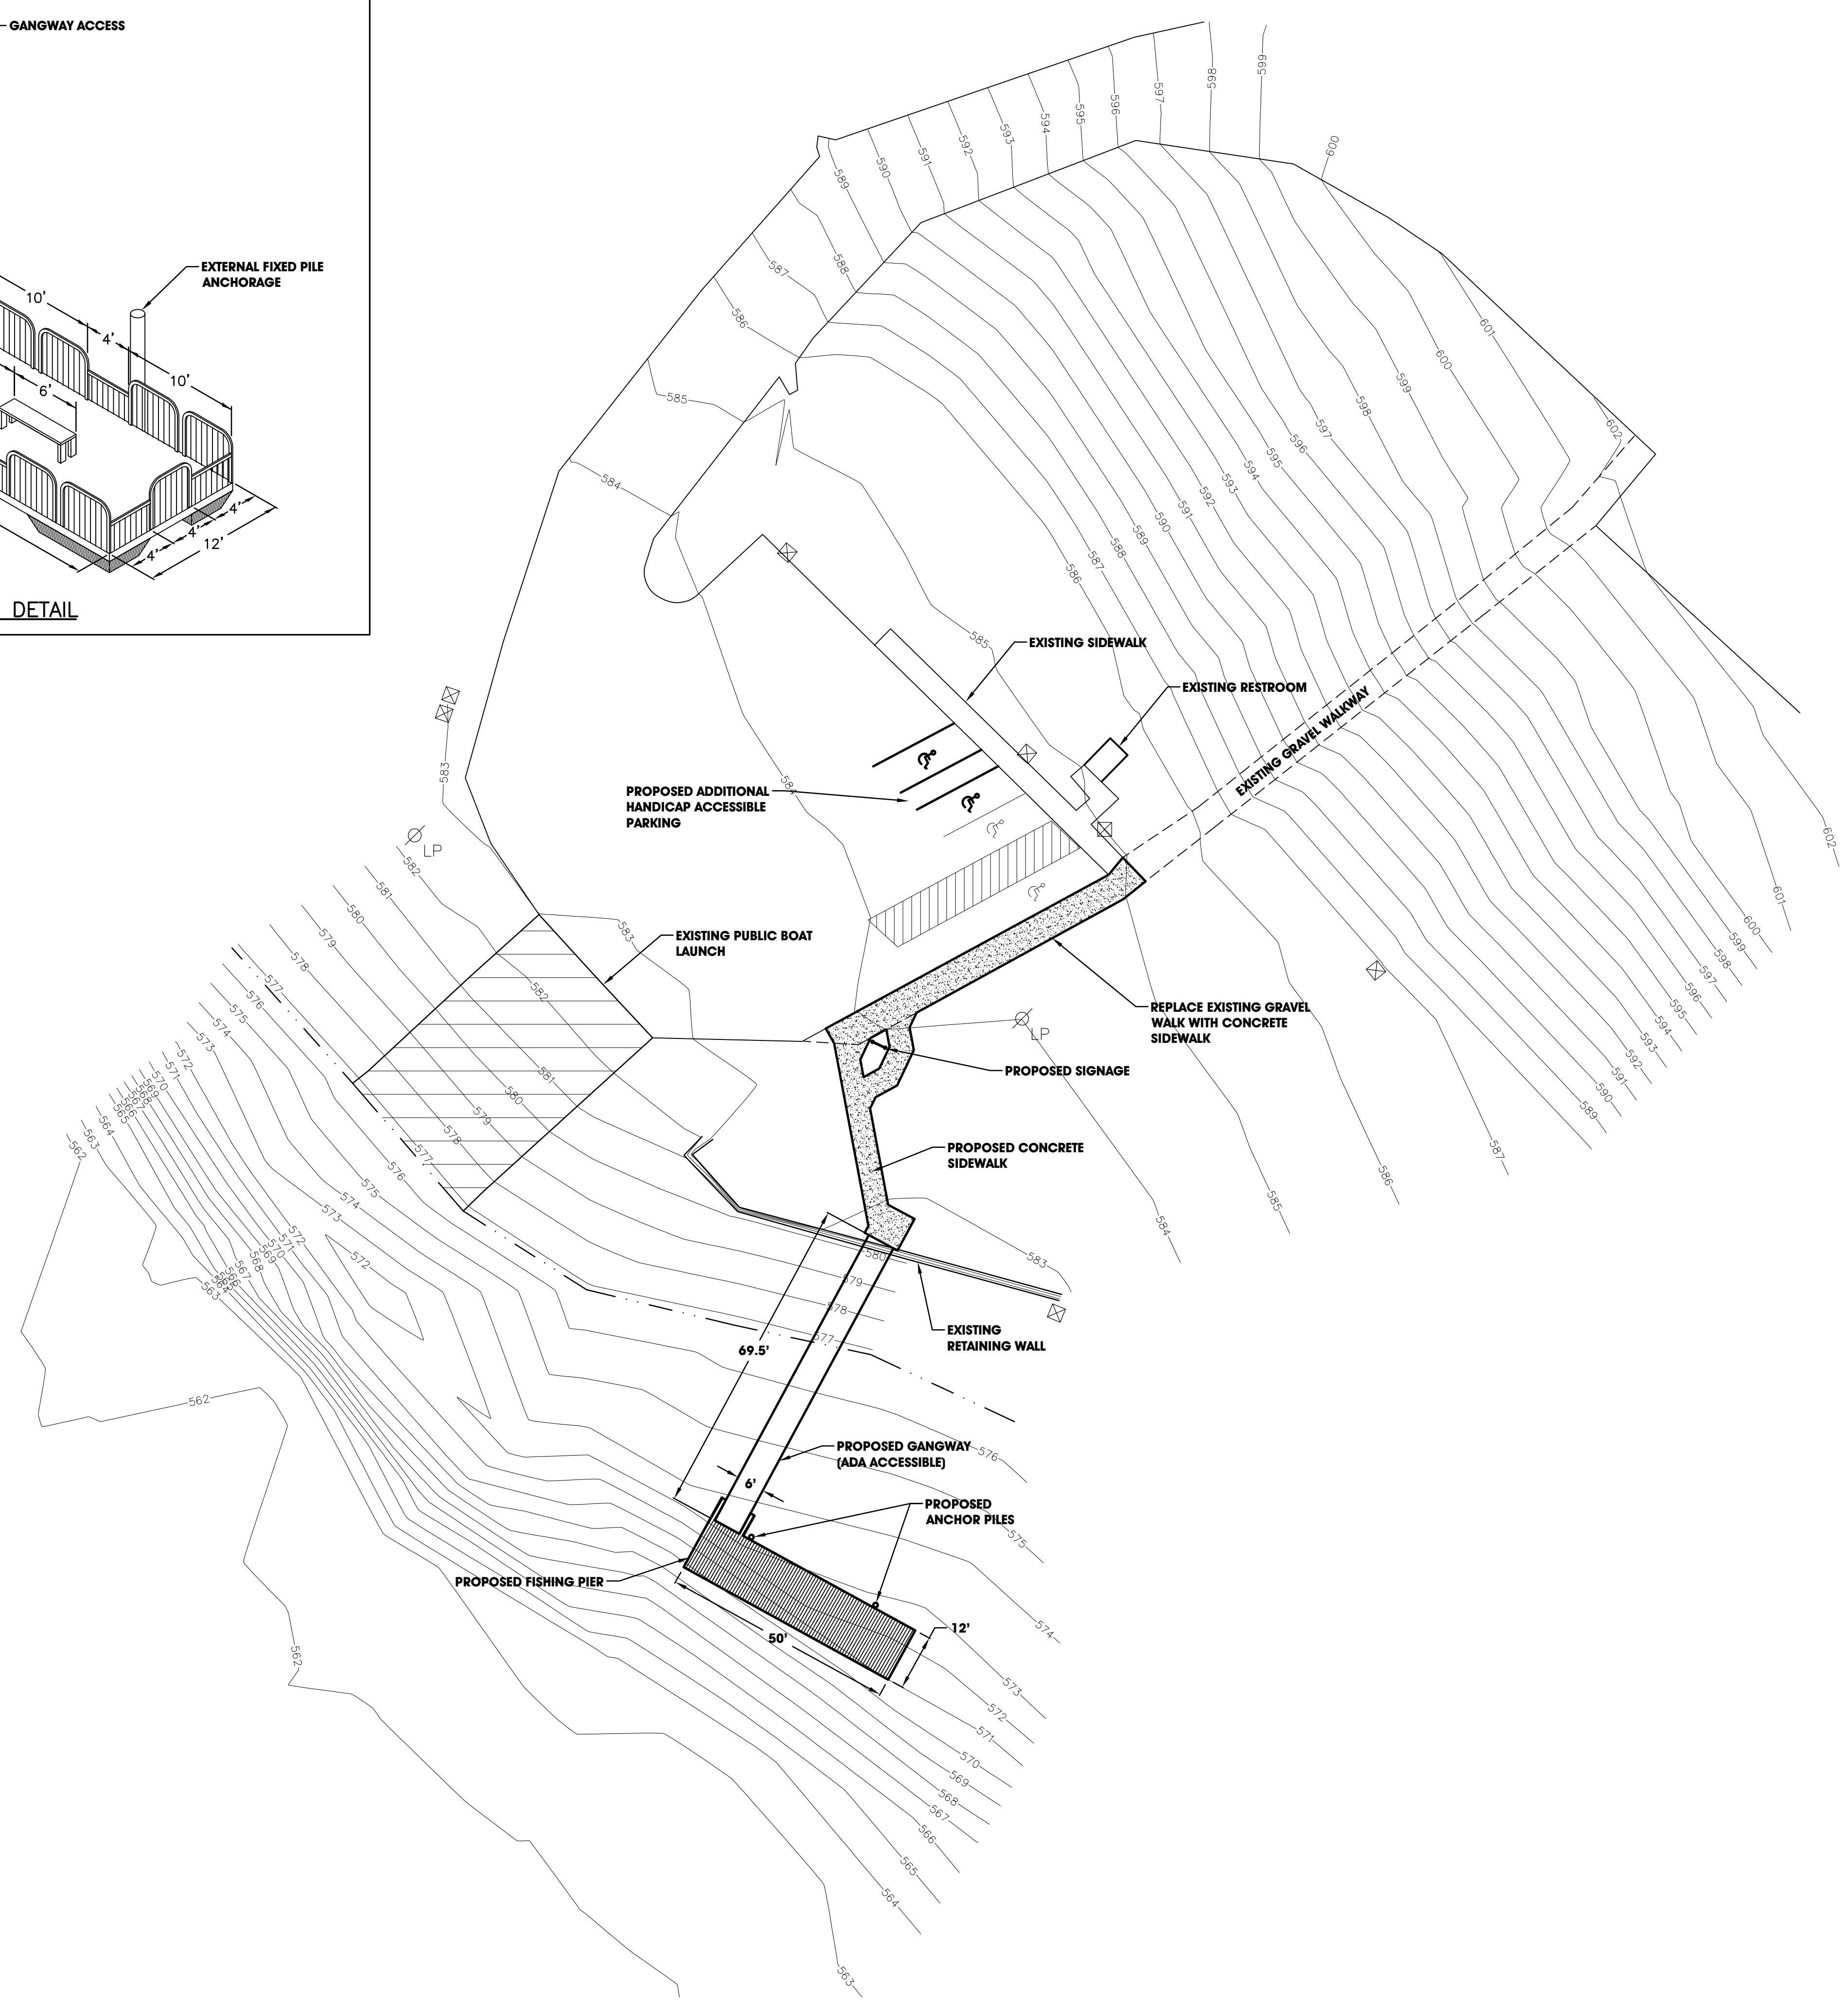

GRAPHIC SCALE

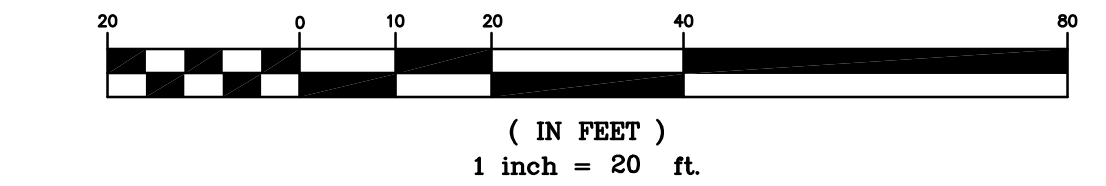

MANISTEE LAKE PUBLIC FISHING PIER – STRONACH SITE

NO.	REVISION DESCRIPTION:	BY:	DATE:

ABONMARCHÉ CONSULTANTS, INC.
 361 First Street
 Manistee, Michigan
 231-723-1198
 FAX 231-723-1194

Benton Harbor, MI
 Indianapolis, IN
 South Bend, IN
 Ft. Wayne, IN

ARCHITECTS / ENGINEERS / SURVEYORS / PLANNERS

DRAWING TITLE:
FISHING PIER PRELIMINARY SITE PLAN

SCALES: VERTICAL: N.A. HORIZONTAL: 1" = 20' DATE: APRIL 22, 2008 DESIGNED: RBB DRAWN: DJL APPROVED: JOB NO. M80243	SHEET 1 OF 1 SHEETS
---	----------------------------------

E:\CIVIL\PROJECTS\ABONMARCHÉ\STRONACH SITE\BASE.dwg, 24/04/2008 8:18:39 AM, mitchell, 1:1